

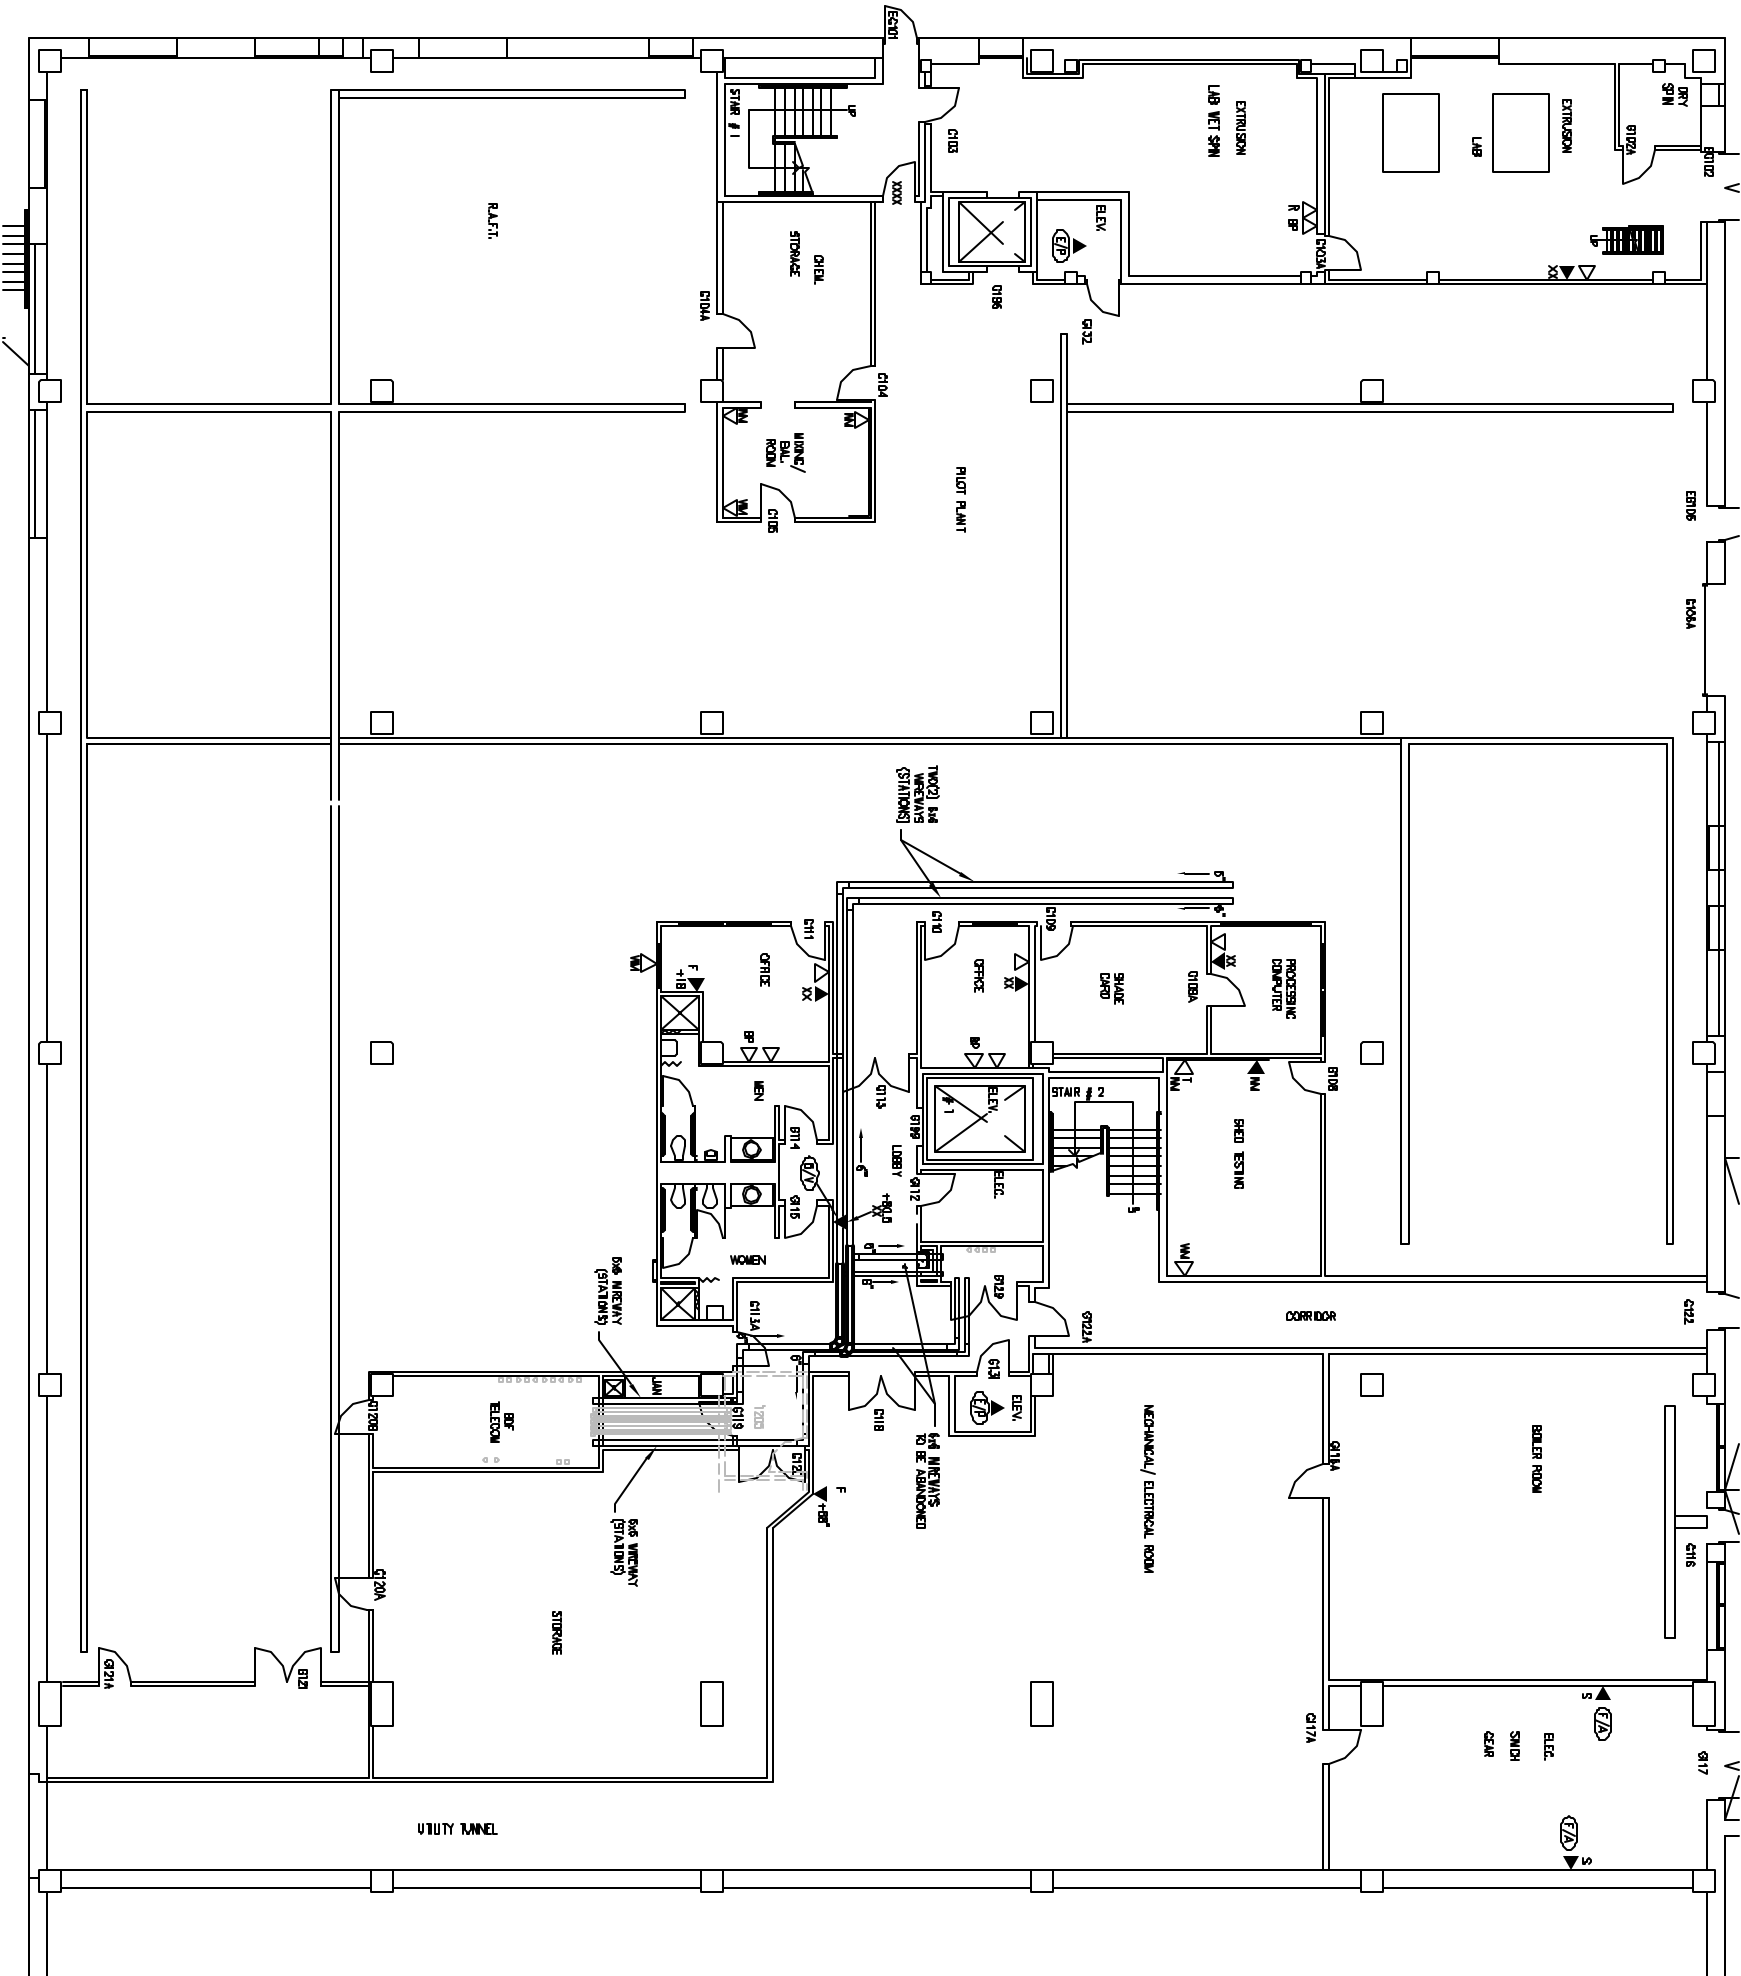


MEZZANINE
SCALE 1/8"=1'
0 4 8 12

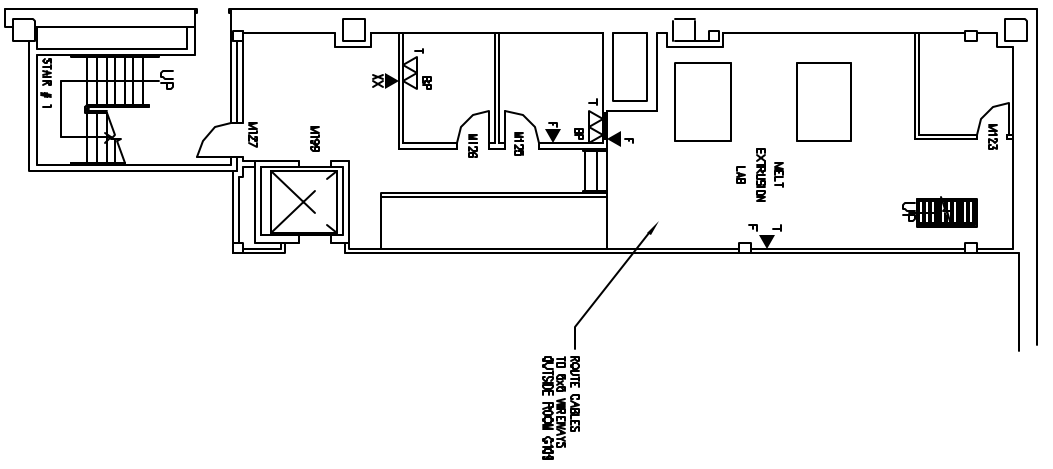

GROUND FLOOR PLAN
SCALE 1/8"=1'
0 4 8 12

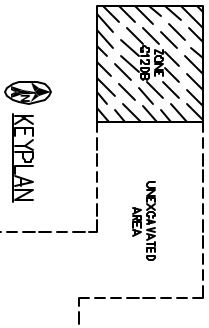

KEYPLAN

Textiles/Wiring/200xT2-1

DATE: 08/08/03
REV:
DESIGNED: GHP
CHECKED: ERR
DRAWN: THS

FACTORY NO. 700
PROJECT NO. ADR

COLLEGE OF TEXTILES
TELECOMMUNICATIONS
WIRING INSTALLATION PHASE
BDF ZONE G120B
GROUND FLOOR PLAN

NC STATE UNIVERSITY
COMMUNICATION TECHNOLOGIES
CAMPUS BOX 7208, RALEIGH, NC
27695-7208 (919)-515-4073

ComTech

W T2-1
SHEET 18 of 52